


Scale 1" = 10000'

# DISTRICT 4

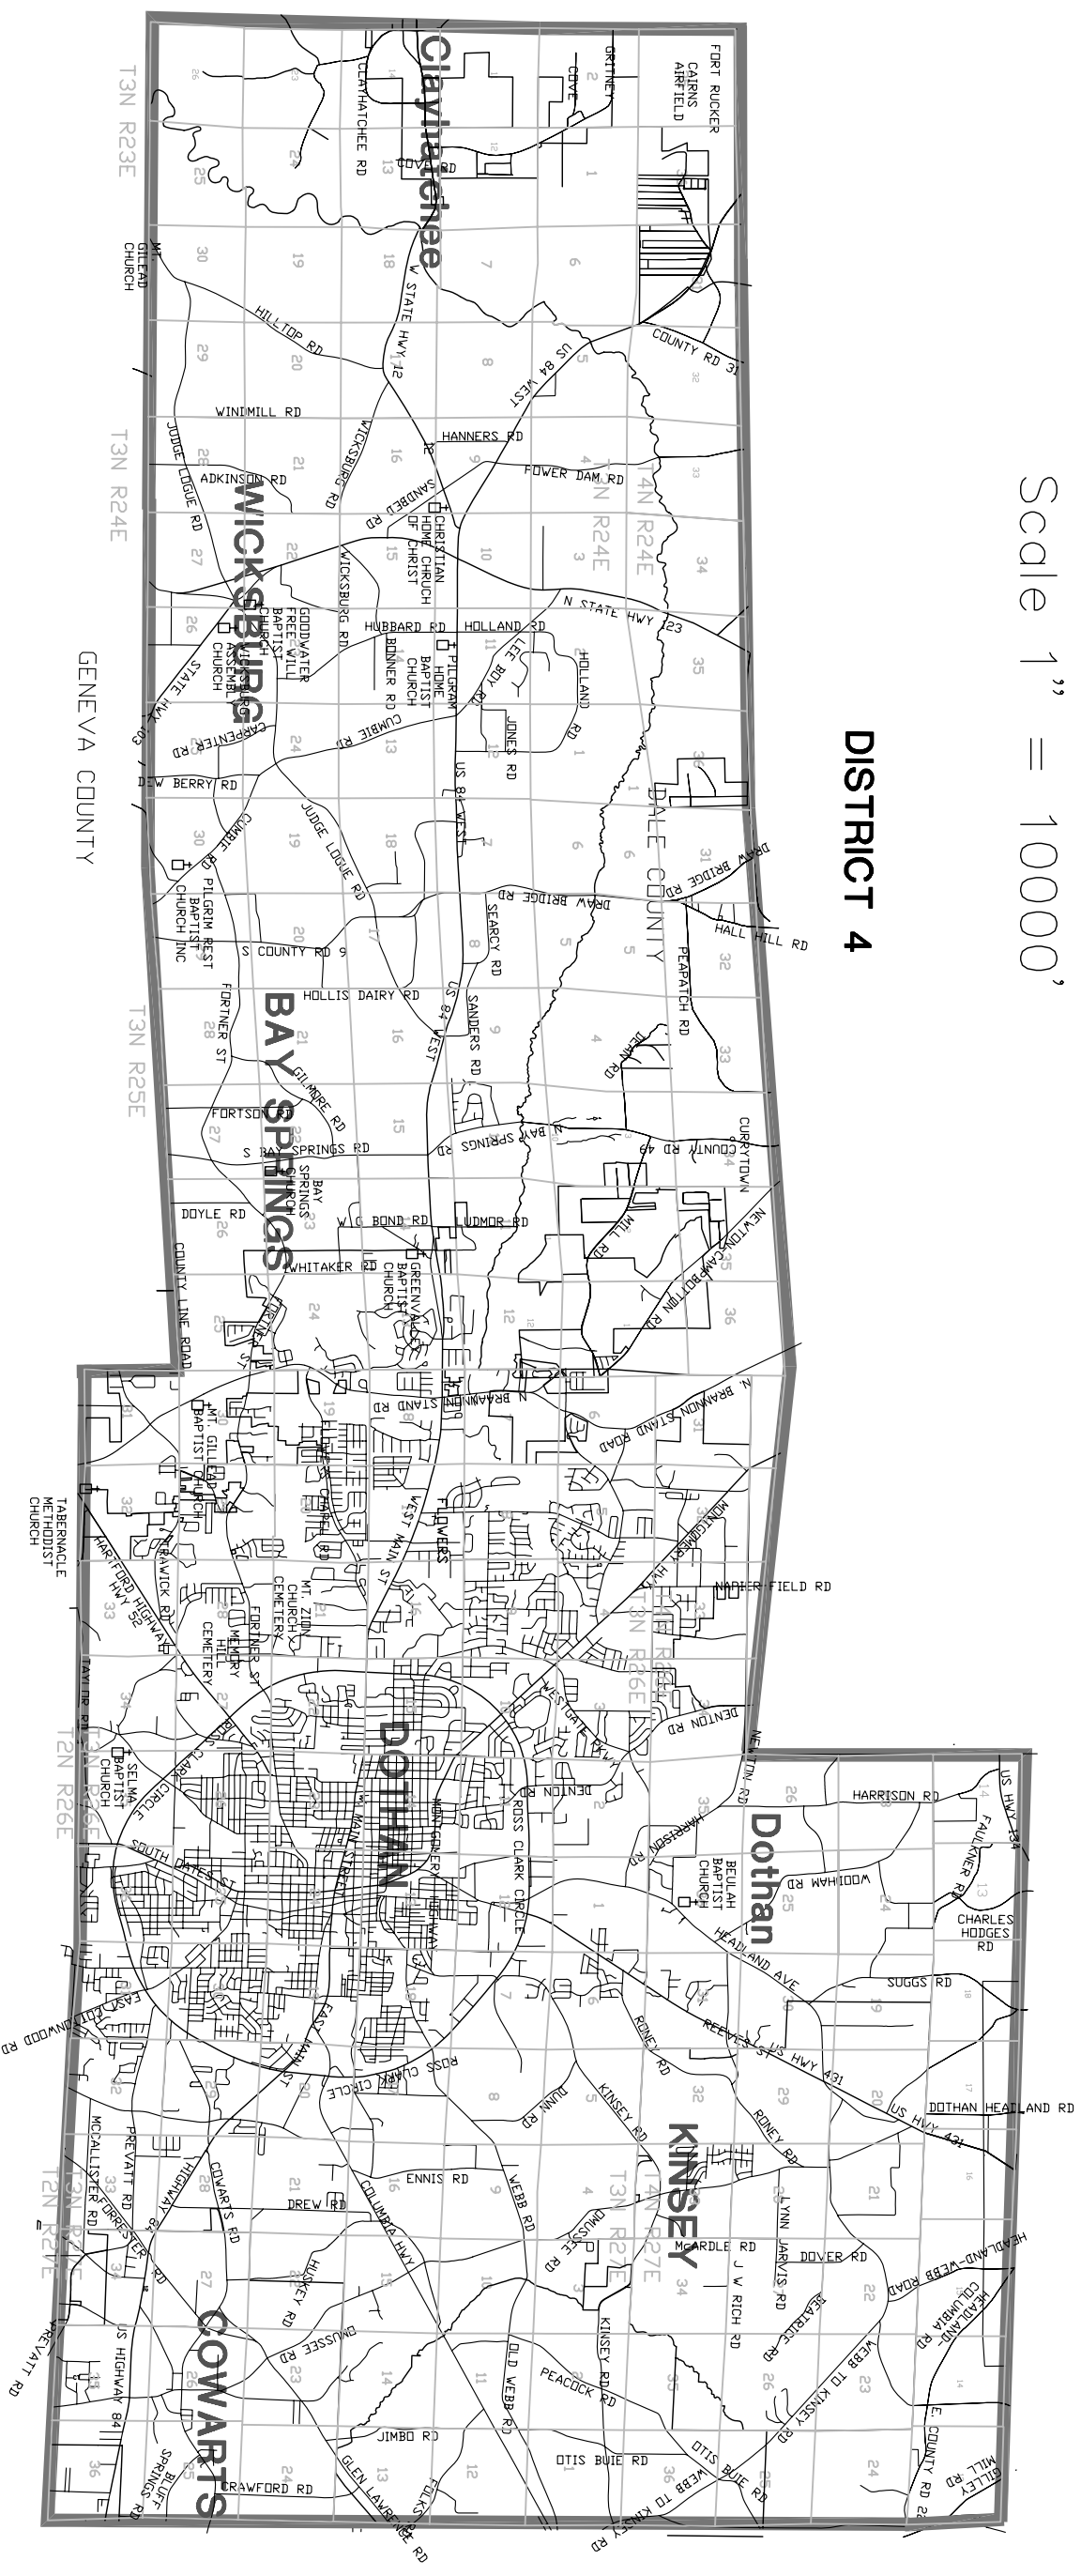

PROJECT No.  
0005-09

DATE: FEBRUARY, 2009  
SCALE: 1" = 9000'

DRAWN BY:  
C. BARRON

APPROVED BY:  
P. SANTORA

REVISIONS:

**WIREGRASS ELECTRIC COOPERATIVE**  
**DISTRICT MAP**  
**DISTRICT 4**

**Northstar**  
**Engineering**  
**Services**

MUNICIPAL DESIGN, AIRPORT DESIGN,  
SITE PLANNING AND DEVELOPMENT,  
SURVEYING, AND SURVEYING

PHONE (334)673-9895  
FAX (334) 673-1846

2431 HATFORD HIGHWAY DOTHAN, ALABAMA 36305

AL. CERT. OF AUTH.  
CA-18966, CA-062115  
FL. CERT. OF AUTH.  
265312  
GA. CERT. OF AUTH.  
003129  
MS. CERT. OF AUTH.  
E-00001825

SHEET **1**  
OF **1**