 



DISTRICT 6

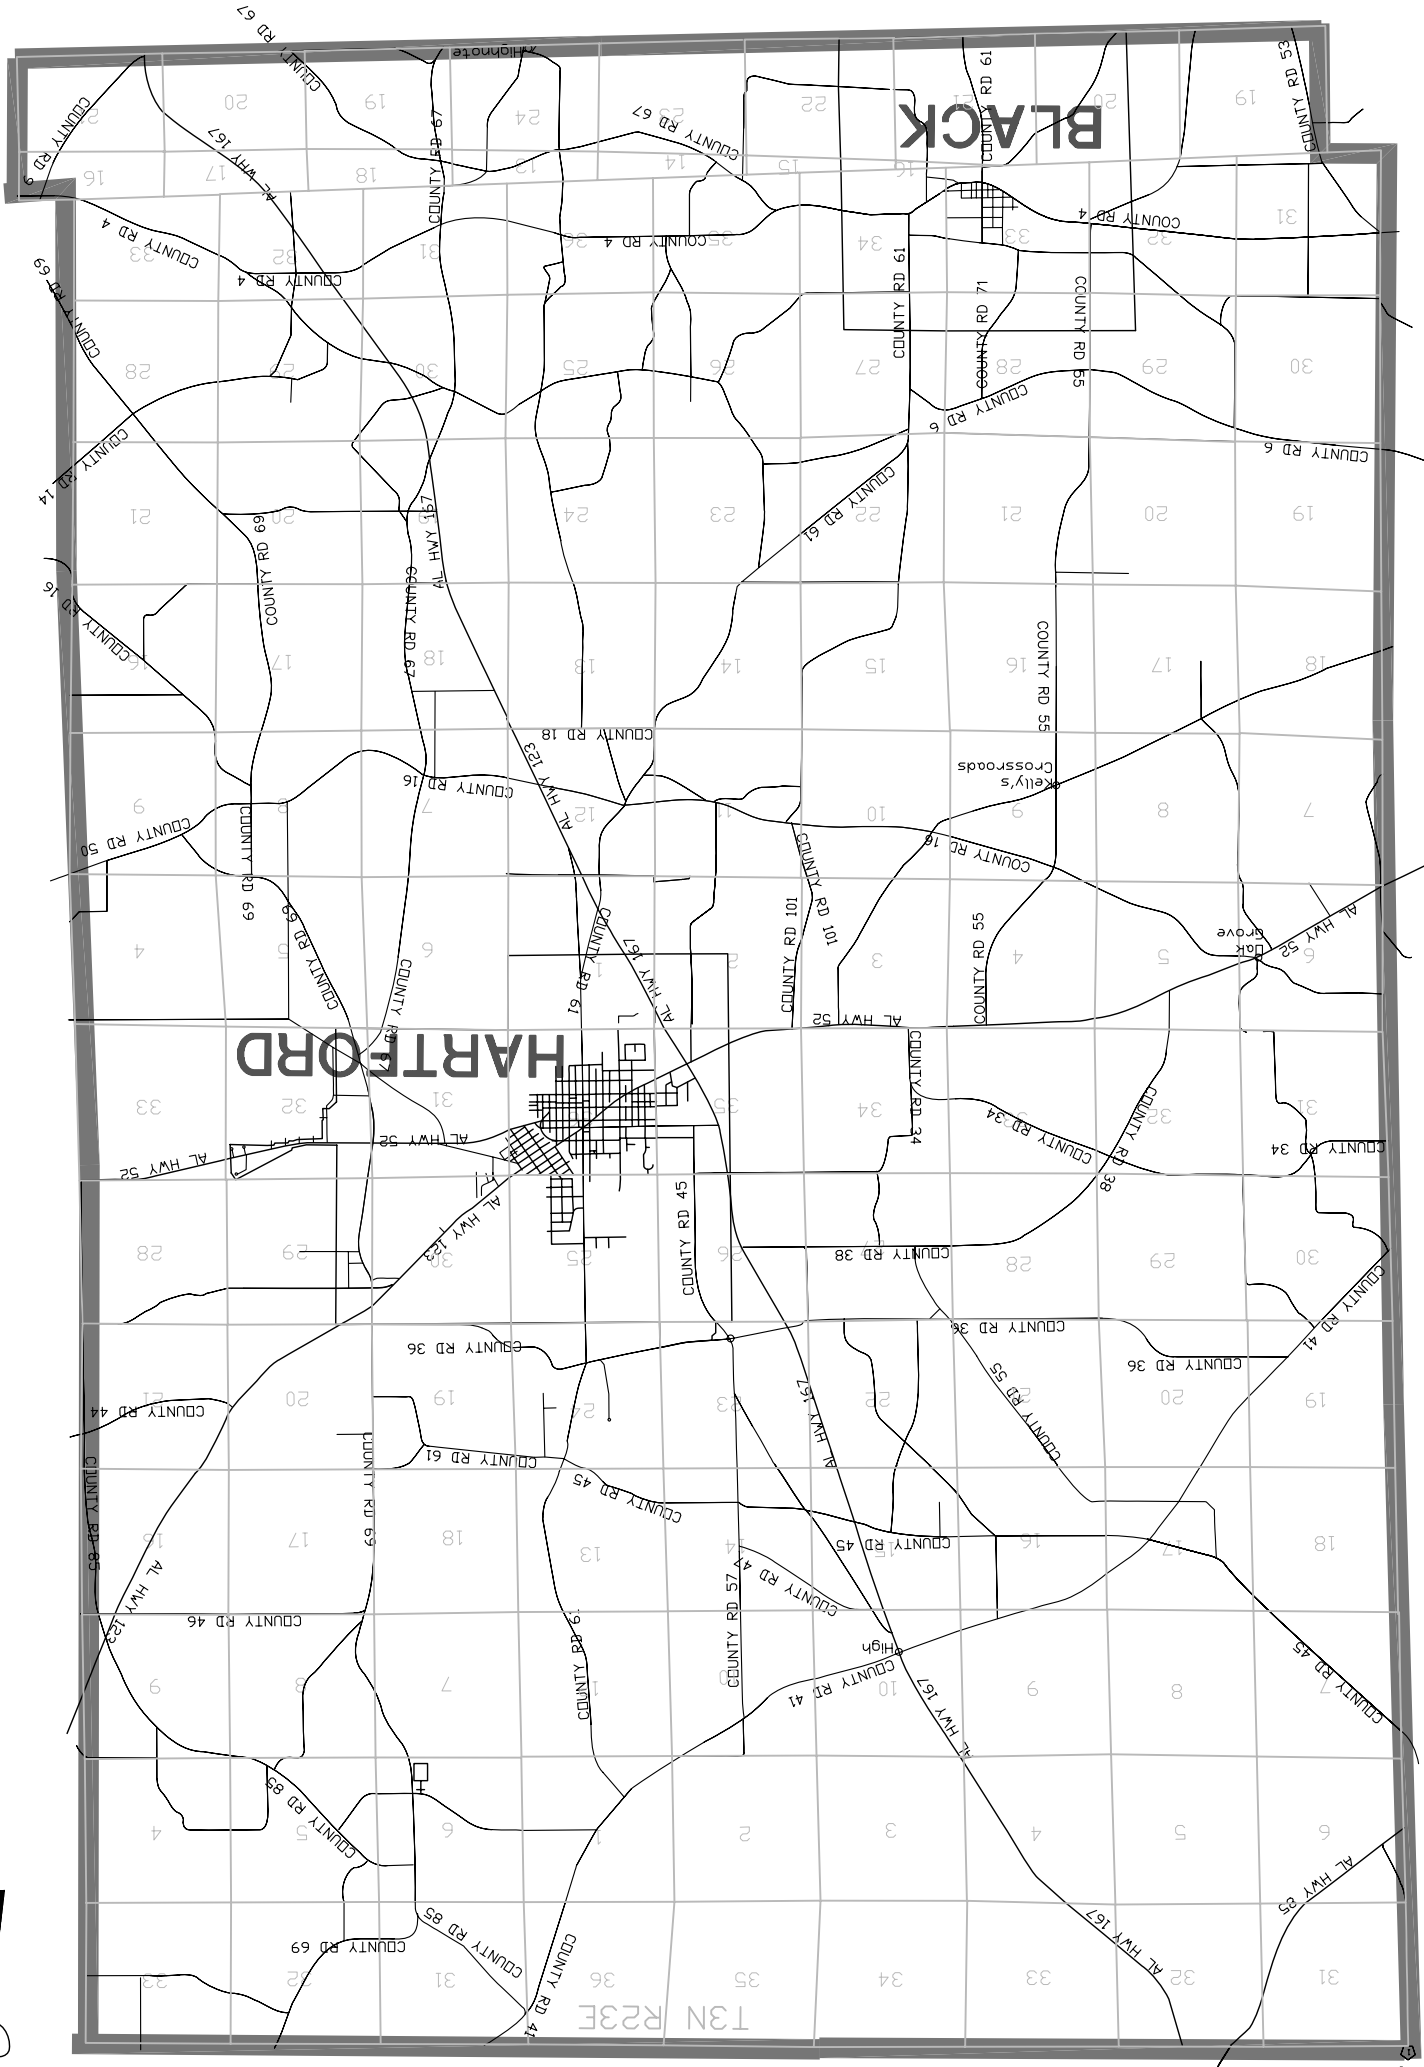

Scale 1" = 7000'

PROJECT No.
0005-09
DATE: FEBRUARY, 2009
SCALE: 1" = 7000'

DRAWN BY:
C. BARRON
APPROVED BY:
P. SANTORA

REVISIONS:

WIREGRASS ELECTRIC COOPERATIVE
DISTRICT MAP
DISTRICT 6

Northstar
Engineering
Services
MUNICIPAL DESIGN, AIRPORT DESIGN,
SITE PLANNING AND DEVELOPMENT,
SUBDIVISIONS, AND SURVEYING
PHONE (334)673-9895
FAX (334) 673-1846
2431 HATFORD HIGHWAY DOTHAN, ALABAMA 36305

AL CERT. OF AUTH.
GA-1898E, GA-0211S
FL CERT. OF AUTH.
028312
GA CERT. OF AUTH.
003129
MS CERT. OF AUTH.
E-00001825

SHEET
OF
1
1